



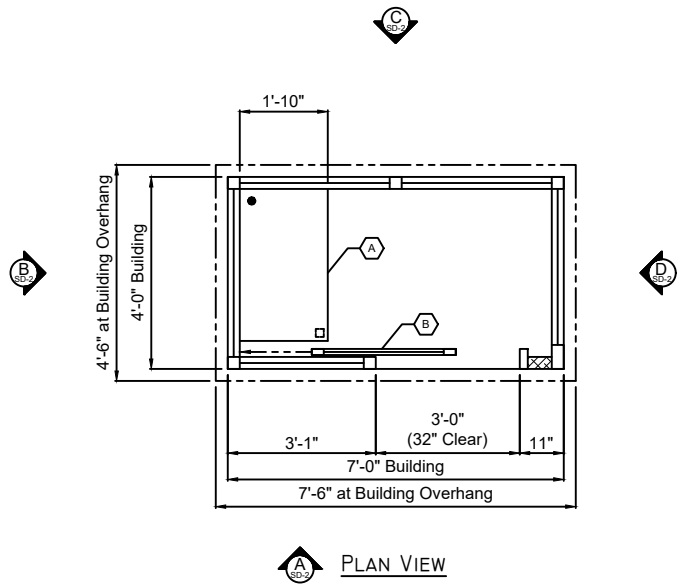

EQUIPMENT

- A. COUNTER WITH 2" GROMMET HOLE. TOP OF COUNTER LOCATED 42" ABOVE FLOOR.
- B. SLIDING DOOR, FULLY WEATHER-STRIPPED WITH HOOK BOLT LOCKSET, BALL BEARING HANGERS, ALUMINUM TRACK WITH FIXED GLASS WINDOW, UPPER HALF.

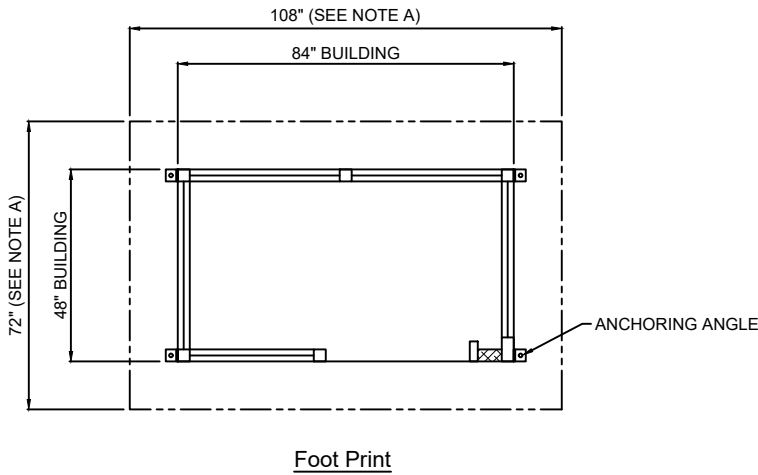


NOTE A: SUGGESTED MINIMUM CONCRETE SLAB/FOUNDATION

THIS UNIT MUST BE ANCHORED TO CONCRETE SLAB/FOUNDATION

FAILURE TO SECURELY ANCHOR BOOTH MAY RESULT IN OVERTURNING OF UNIT AND SERIOUS INJURY OR DEATH TO OCCUPANT OR TO OTHERS.

DESIGN OF SLAB/FOUNDATION BY OTHERS. CONSULT A PROFESSIONAL ENGINEER FAMILIAR WITH APPLICABLE LOADS AND SITE CONDITIONS FOR THE LOCATION.

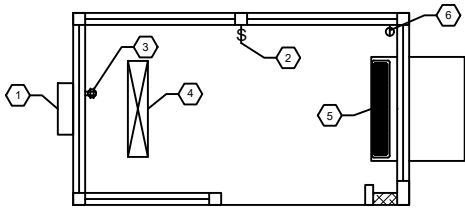

Electrical Plan


ELECTRICAL NOTES

1. RAIN-TIGHT, 120/240 VOLT, SINGLE PHASE, 12-CIRCUIT LOAD CENTER PANEL (100 AMP, MAIN BREAKER PROVIDED). NOTE: EQUIPMENT LISTED TO BE POWERED BY 240 VOLTS CAN OPERATE ON 208-240 VOLTS POWER.
2. LIGHT SWITCH.
3. 120 VOLT, DOUBLE DUPLEX RECEPTACLE.
4. SURFACE MOUNTED LED LIGHT FIXTURE.
5. 240 VOLT, 12,000 BTU COOL/10,600 BTU HEAT, 208 VOLT, 11,700 BTU COOL/8,600 BTU HEAT, HVAC UNIT WITH WIRELESS REMOTE CONTROL.
6. SINGLE RECEPTACLE 240V/20 AMP FOR HVAC POWER.

FACTORY INSTALLED COMPONENTS NOTES:

- ALL ELECTRICAL COMPONENTS TO BE LISTED BY A (NRTL) NATIONALLY RECOGNIZED TESTING LABORATORY.
- ALL WIRING PER N.E.C. STANDARD.
- ALL WIRING FOR 120/240 VOLT CURRENT CARRYING CONDUCTORS TO BE #12 MINIMUM, THHN ENCLOSED IN SURFACE MOUNTED METALLIC RACEWAYS. EXCEPT CONTROL CIRCUIT WIRING WHICH IS SIZED PER EQUIPMENT SPECIFICATIONS/INSTALLATION REQUIREMENTS.
- ALL BRANCH CIRCUITS HAVE GREEN GROUND CONDUCTOR.

LOCATION OF DEVICE MAY VARY DUE TO MEETING CODE REQUIREMENTS AND PLACEMENT WITHIN THE STRUCTURE

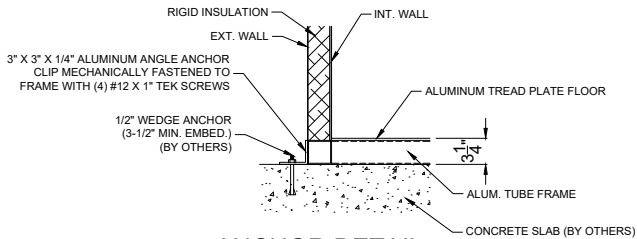

ANCHOR DETAIL

ANCHOR LOCATION AND QUANTITY PER PROJECT DRAWING FOOT PRINT/CALCULATIONS.

CONCRETE FOUNDATION/SLAB DESIGN BY OTHERS

ASSUMED DESIGN IS BASED ON A MINIMUM 6" DEEP, 3,000 PSI MINIMUM (28 DAY ACI 318) REINFORCED.

ASSUMED DESIGN SOIL BEARING COMPACTION VALUE SHALL BE A MINIMUM OF 3,000 PSF.

ASSUMED FOUNDATION/SLAB SHOULD BE A MINIMUM OF 12" WIDER THAN THE BUILDING FOOT PRINT DIMENSIONS. THIS IS TO PROVIDE A 6" CONCRETE BORDER ON EACH SIDE OF THE BUILDING.

THIS DETAIL IS FOR REFERENCE PURPOSES ONLY.THE BUILDING(S) MUST BE SECURELY ANCHORED IN PLACE AND MUST BE PROPERLY GROUNDED.

ADEQUATE SIZED ANCHOR BOLTS SHALL BE USED. THE SIZE AND DEPTH OF THE ANCHORS SHOULD BE OF SUFFICIENT DESIGN TO WITHSTAND THE APPLICABLE WIND SPEED AND SEISMIC LOADS FOR THE LOCATION OF INSTALLATION AND SOIL CONDITIONS.


PLEASE CONSULT A PROFESSIONAL ENGINEER FAMILIAR WITH THESE PARAMETERS FOR THE LOCATION.

FINISH SCHEDULE	
ITEM	DESCRIPTION
Floor	Aluminum Treadplate
Exterior	Pre-Finished White
Interior	Pre-Finished White
Ceiling	Pre-Finished White
Counter	Butcher Block
Safety Glazing	Clear Tempered, Glass


26027_QUICKSHIP_Ax7

Model Number MFI-4070-SL		Approved By:	
Date: 8-11-2026	Drawing Number 26027	Drawn By: DNE	Revision: .
Scale: 1/4" = 1'-0"	Quick Ship 4'-0" x 7'-0"		
MFI Mardan Fabrication, Inc. 41001 Production Drive, Harrison Twp. MI 48045 Phone: 800-882-5820			Drawing Sheet SD-1


NOTE: THIS DRAWING AND DESIGN ARE THE PROPERTY OF MARDAN FABRICATION, INC. (MFI) IT MUST NOT BE REPRODUCED IN ANY MANNER, NOR SHALL IT BE SUBMITTED TO OUTSIDE PARTIES FOR EXAMINATION WITHOUT OUR CONSENT. IT SHALL BE USED ONLY AS A MEANS OF REFERENCE TO WORK DESIGNED AND FURNISHED BY MARDAN. MARDAN RESERVES THE RIGHT TO MAKE CHANGES TO DESIGN FOR ENGINEERING PURPOSES WITHOUT NOTICE. REVISIONS MAY NOT BE NOTED.

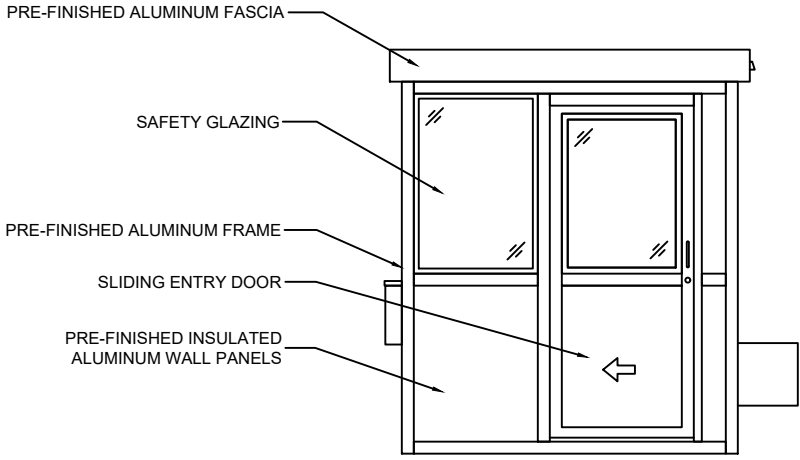


Elevation "A"

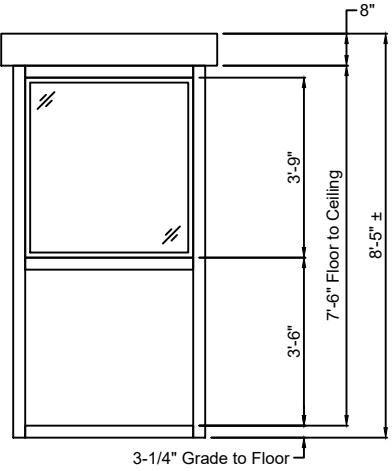

Elevation "B"

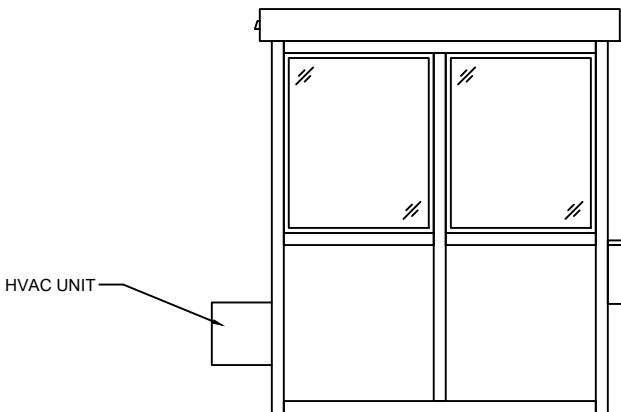

Elevation "C"

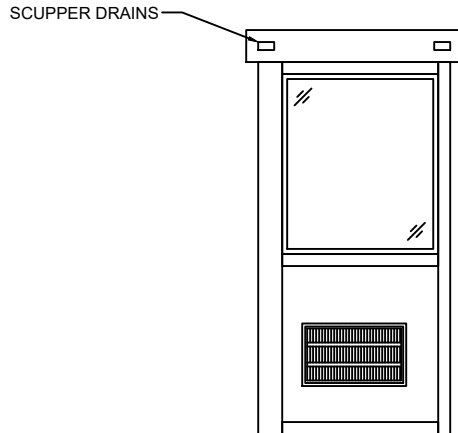

Elevation "D"

NOTE: THIS DRAWING AND DESIGN ARE THE PROPERTY OF MARDAN FABRICATION, INC. (MFI). IT MUST NOT BE REPRODUCED IN ANY MANNER, NOR SHALL IT BE SUBMITTED TO OUTSIDE PARTIES FOR EXAMINATION WITHOUT OUR CONSENT. IT SHALL BE USED ONLY AS A MEANS OF REFERENCE TO WORK DESIGNED AND FURNISHED BY MARDAN. MARDAN RESERVES THE RIGHT TO MAKE CHANGES TO DESIGN FOR ENGINEERING PURPOSES WITHOUT NOTICE. REVISIONS MAY NOT BE NOTED.

Model Number MFI-4070-SL		Approved By:	
Date: 8-11-2026	Drawing Number 26027	Drawn By: DNE	
Scale: 1/4" = 1'-0"		Revision: .	
Quick Ship 4'-0" x 7'-0"			
 Mardan Fabrication, Inc. 41001 Production Drive, Harrison Twp. MI 48045 Phone: 800-882-5820			Drawing Sheet SD-2